
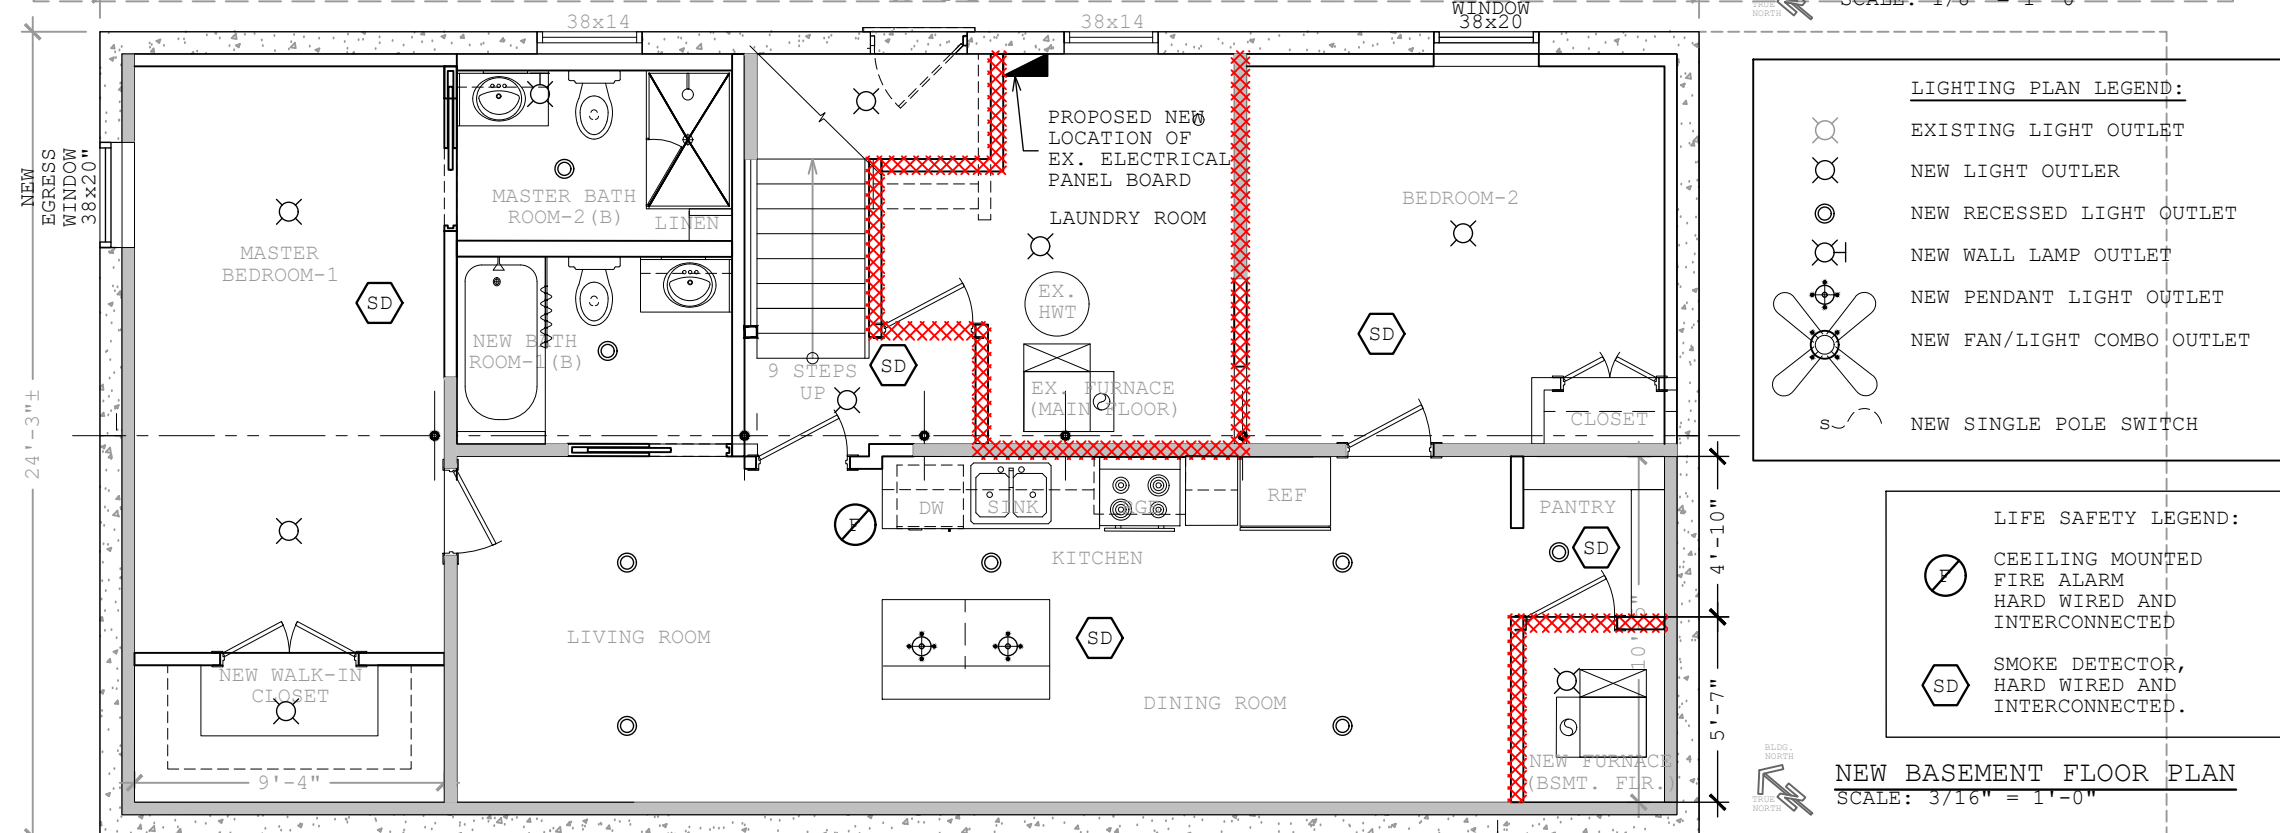


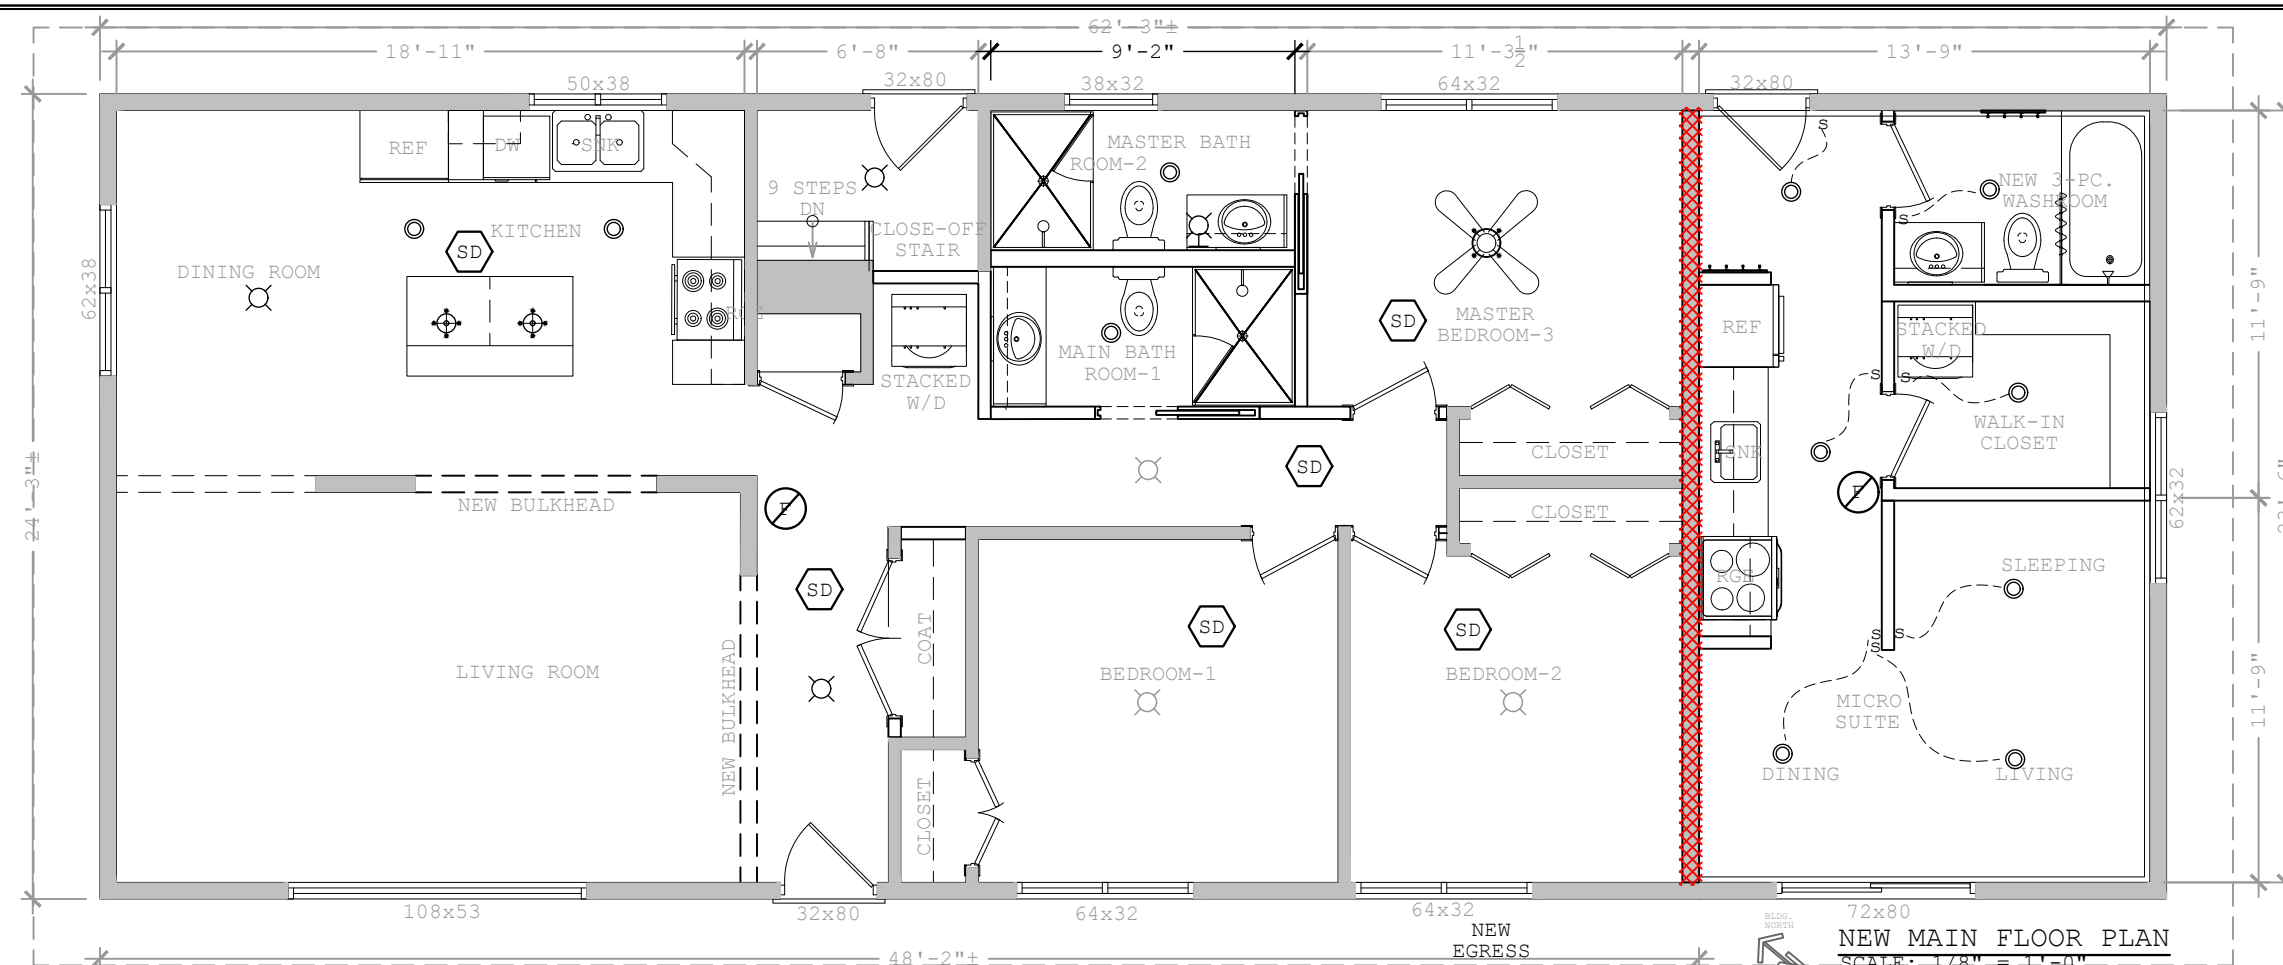

NOTES

NOTE:
- ALL HALLWAY LIGHTS LOCATION
TO REMAIN, (WALL AND CEILING)

LEGEND

CONSTRUCTION LEGEND:

NEW AND EXT'G. WALLS
TO BE ENCLOSED AND
SEALED, MIN. ½" GYPSUM
BOARD, EACH SIDE. TAPED,
MUDDIED, AND PAINTED.

ENGINEER'S STAMP

PERMIT STAMP

[illegible]

RENTAL PROPERTY
BASEMENT LIGHTING PLAN
MAIN FLOOR LIGHTING PLAN

LOC. @ 2 FALCON CRESCENT
ST. ALBERT, ALBERTA

SCALE:
AS SHOWN

CLIENT:

BOLSON
ENGINEERING
AND
ENVIRONMENTAL SERVICES

21707-80 Ave.
EDMONTON, AB
T5T-4S2
www.bolson.ca
PH:780-668-8571

JOB NUMBER:
100-2500

DWG NUMBER:
L1.0

EV:
A